



Indiana Department of Environmental Management Office of Water Quality Wetlands Section

Publication Date:
November 15, 2024

Closing Date:
December 6, 2024

PUBLIC NOTICE

IDEM ID Number:
2024-919-71-ENH-WQC

Corps of Engineers ID Number:
LRL-2023-00882-sjk

To all interested parties:

This letter shall serve as a formal notice of the receipt of an application for **Section 401 Water Quality Certification** by the Indiana Department of Environmental Management (IDEM). The purpose of the notice is to inform the public of active applications submitted for water quality certification under Section 401 of the Clean Water Act (33 U.S.C. § 1341) and to solicit comments and information on any impacts to water quality related to the proposed project. IDEM will evaluate whether the project complies with Indiana's water quality standards as set forth at 327 IAC 2.

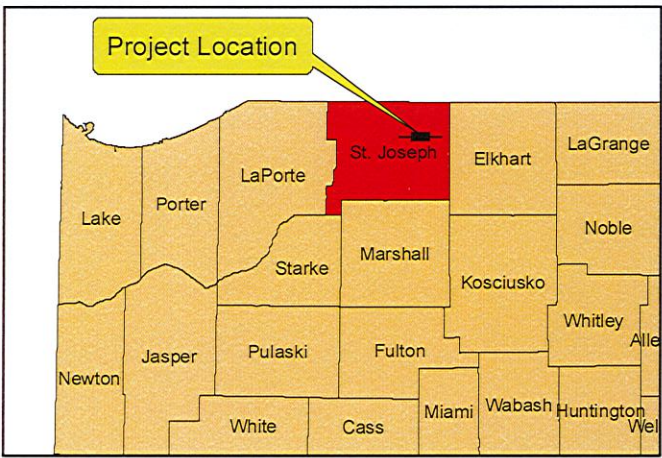
- | | | | |
|--------------------------------|---|------------------|---|
| 1. Applicant: | City of Mishawaka
Attention: Christine Jamrose
100 Linconway West
Mishawaka, IN 46544 | 2. Agent: | Lawson-Fisher Associates P.C.
Attention: Christopher Jeter
525 West Washington Street
South Bend, IN 46601 |
| 3. Project location: | Latitude 41.661712, Longitude -86.171681
646 Lincolnway East, Mishawaka, Saint Joseph County | | |
| 4. Affected waterbody: | Saint Joseph River | | |
| 5. Project Description: | Installation of a 72-inch outfall, retaining wall, and riprap and the reconstruction of an embankment.
Additional information may be found online at https://www.in.gov/idem/5474.htm | | |

Comment period: Any person or entity who wishes to submit comments or information relevant to the aforementioned project may do so by the closing date noted above. Only comments or information related to water quality or potential impacts of the project on water quality can be considered by IDEM in the water quality certification review process.

Public Hearing: Any person may submit a written request that a public hearing be held to consider issues related to water quality in connection with the project detailed in this notice. The request for a hearing should be submitted within the comment period to be considered timely. The request should also state the reason for the public hearing as specifically as possible to assist IDEM in determining whether a public hearing is warranted.


Questions? Additional information may be obtained from Emersyn Harriman, Project Manager, by phone at 317-409-7580 or by e-mail at eharrima@idem.in.gov. Please address all correspondence to the project manager and reference the IDEM project identification number listed on this notice. Indicate if you wish to receive a copy of IDEM's final decision. Written comments and inquiries may be forwarded to -


Indiana Department of Environmental Management
100 North Senate Avenue
MC65-42 WQS IGCN 1255
Indianapolis, Indiana 46204-2251 FAX: 317/232-8406



City of Mishawaka, Indiana
Third Street Sewer Improvements
Phase III
St. Joseph County, Indiana
Project Location Map

LFA
LAWSON-FISHER ASSOCIATES P.C.
525 W WASHINGTON AVENUE
SOUTH BEND, INDIANA 46601
PH. (574) 234-3167

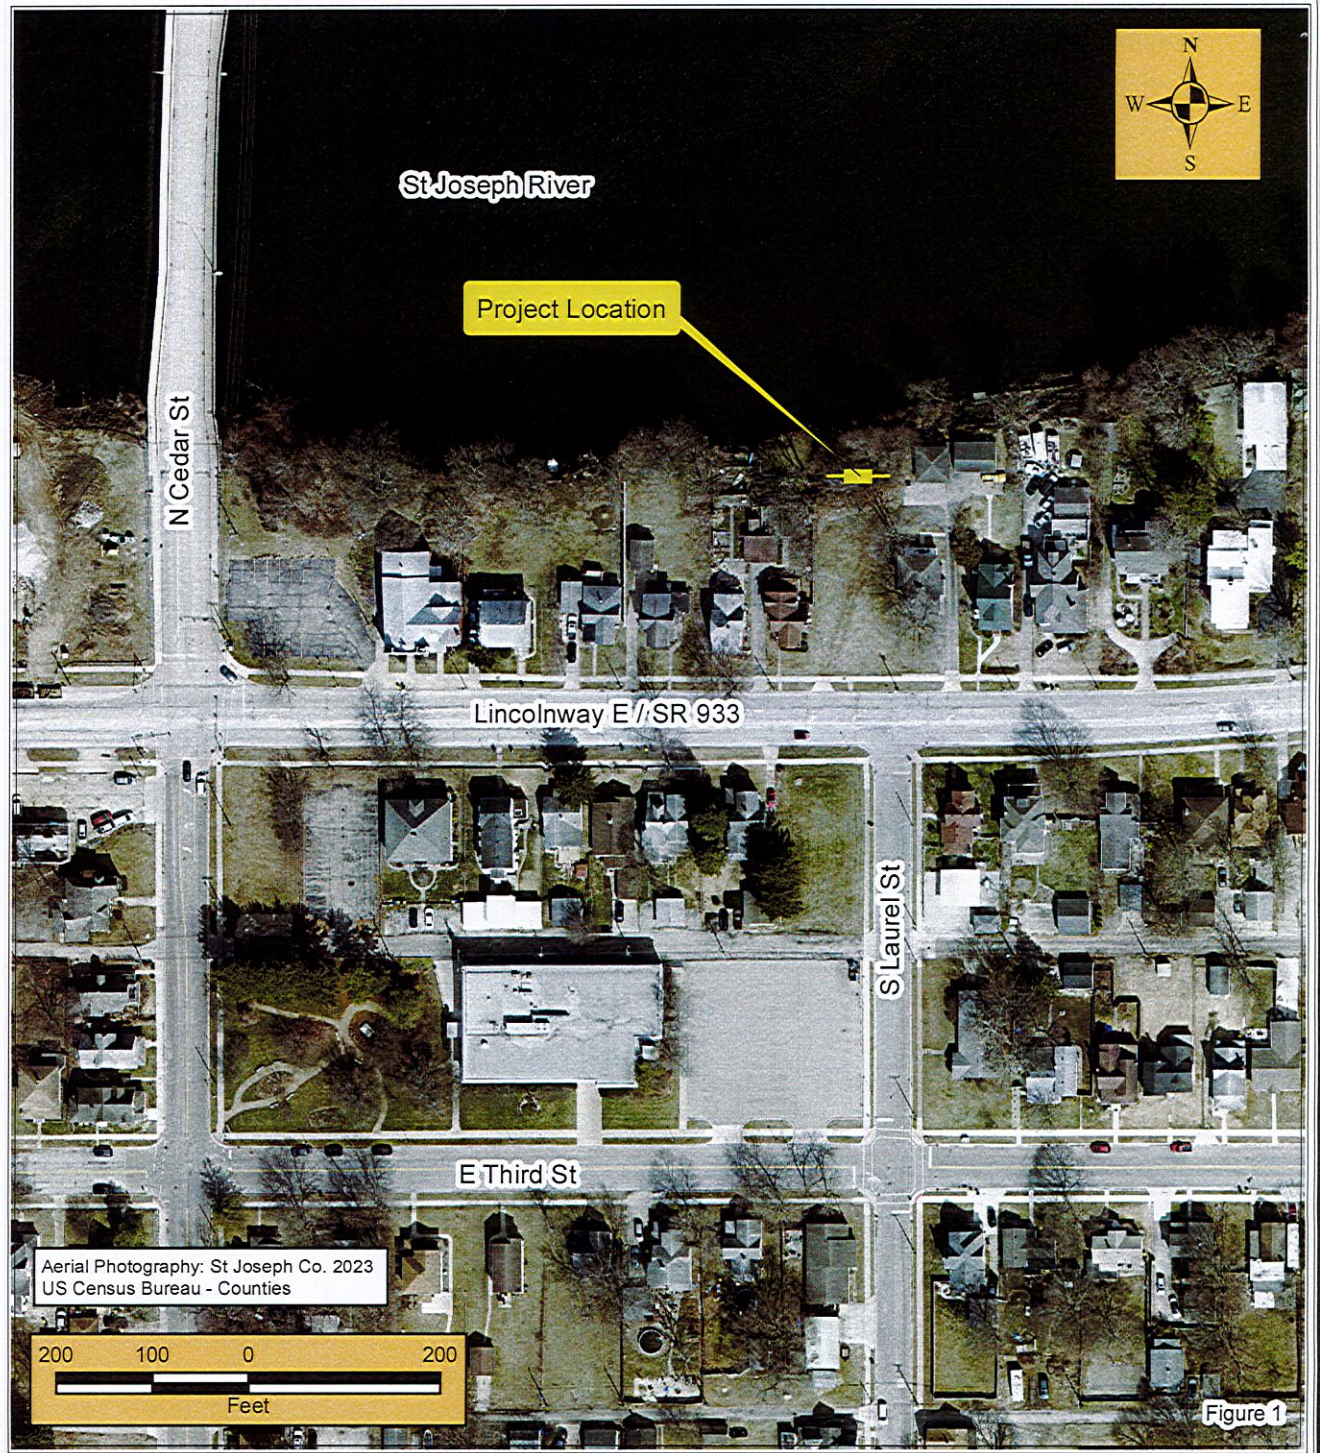

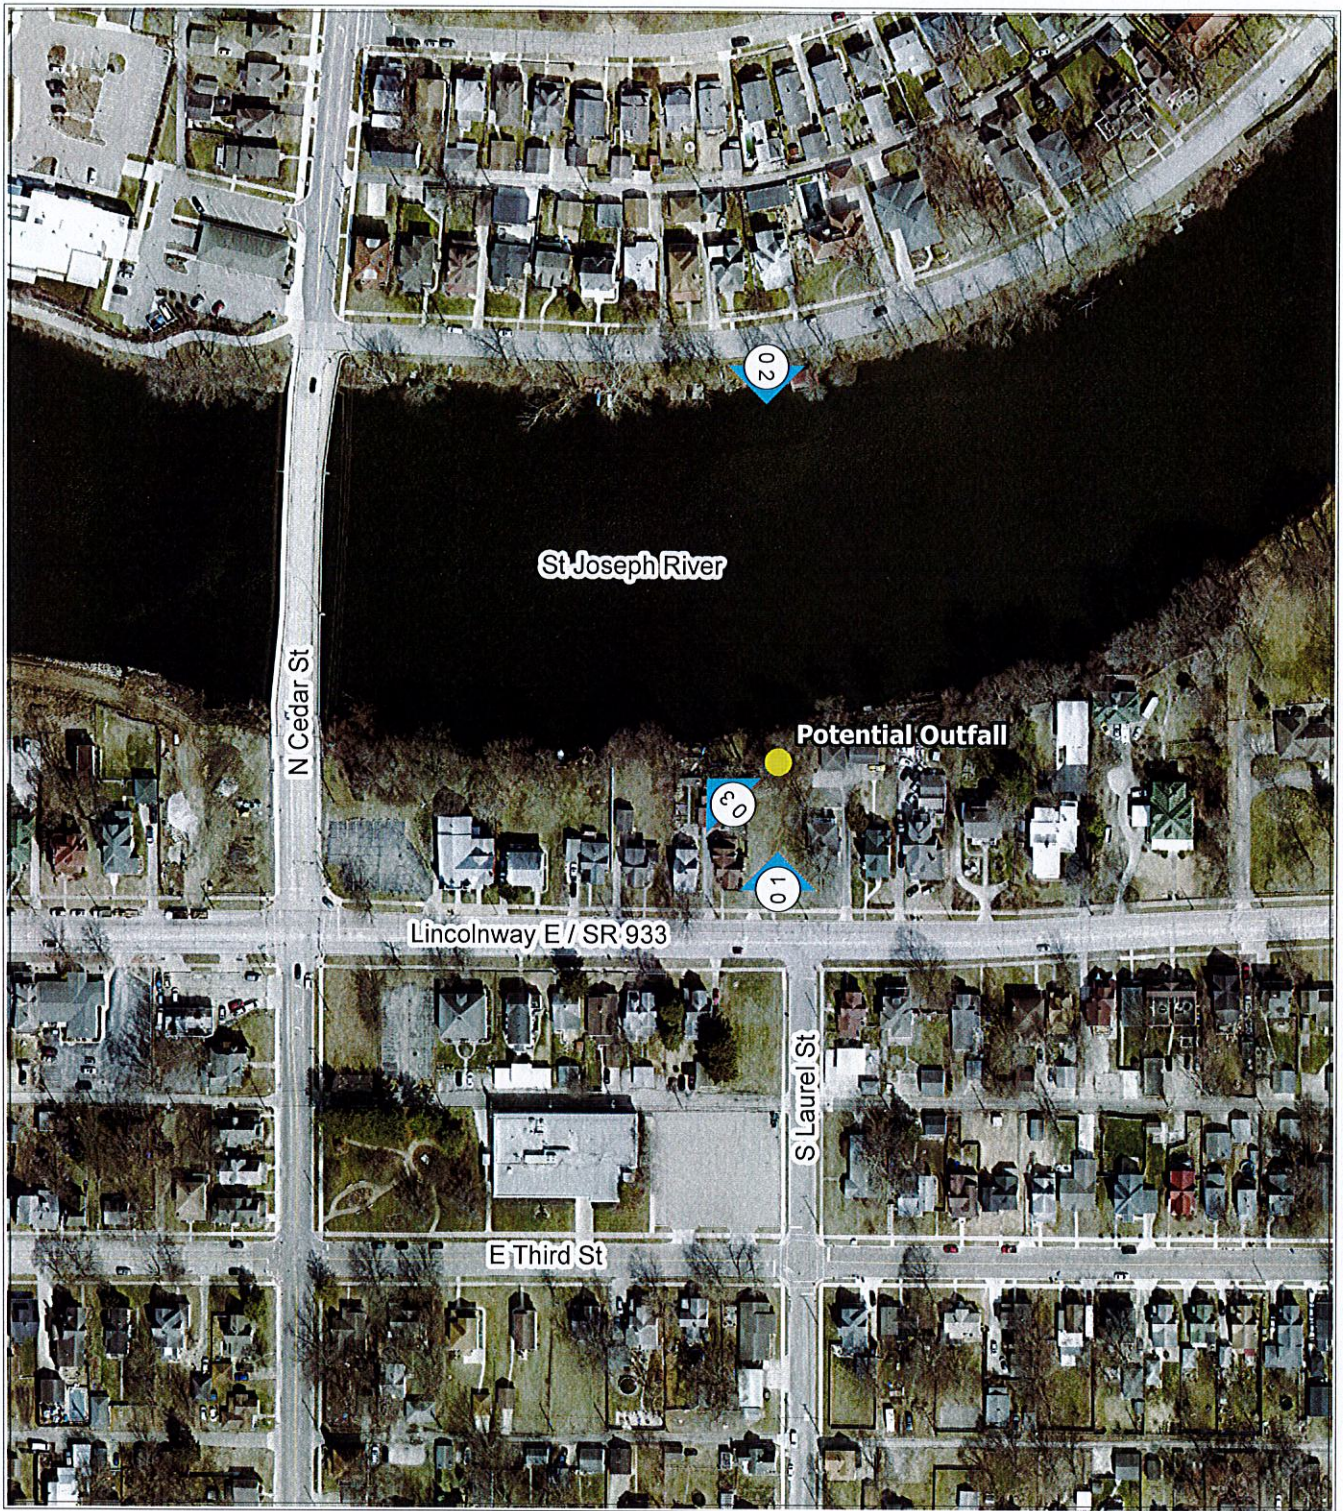


 Photo Orientation

Figure 3

LFA
LAWSON-FISHER ASSOCIATES P.C.
525 W WASHINGTON AVENUE
SOUTH BEND, INDIANA 46601
PH. (574) 234-3167

City of Mishawaka, Indiana
Third Street Sewer Improvements
Phase III - Outfall Location
Photo Orientation Map
St Joseph County Aerial, 2023
September 2024




CITY OF MISHAWAKA
THIRD STREET SEWER IMPROVEMENTS PHASE III
City Project No.: MWW-23-015



Photograph 1: Looking North Along the Proposed Sewer Alignment through City Owned Property - Top of South Riverbank in Background



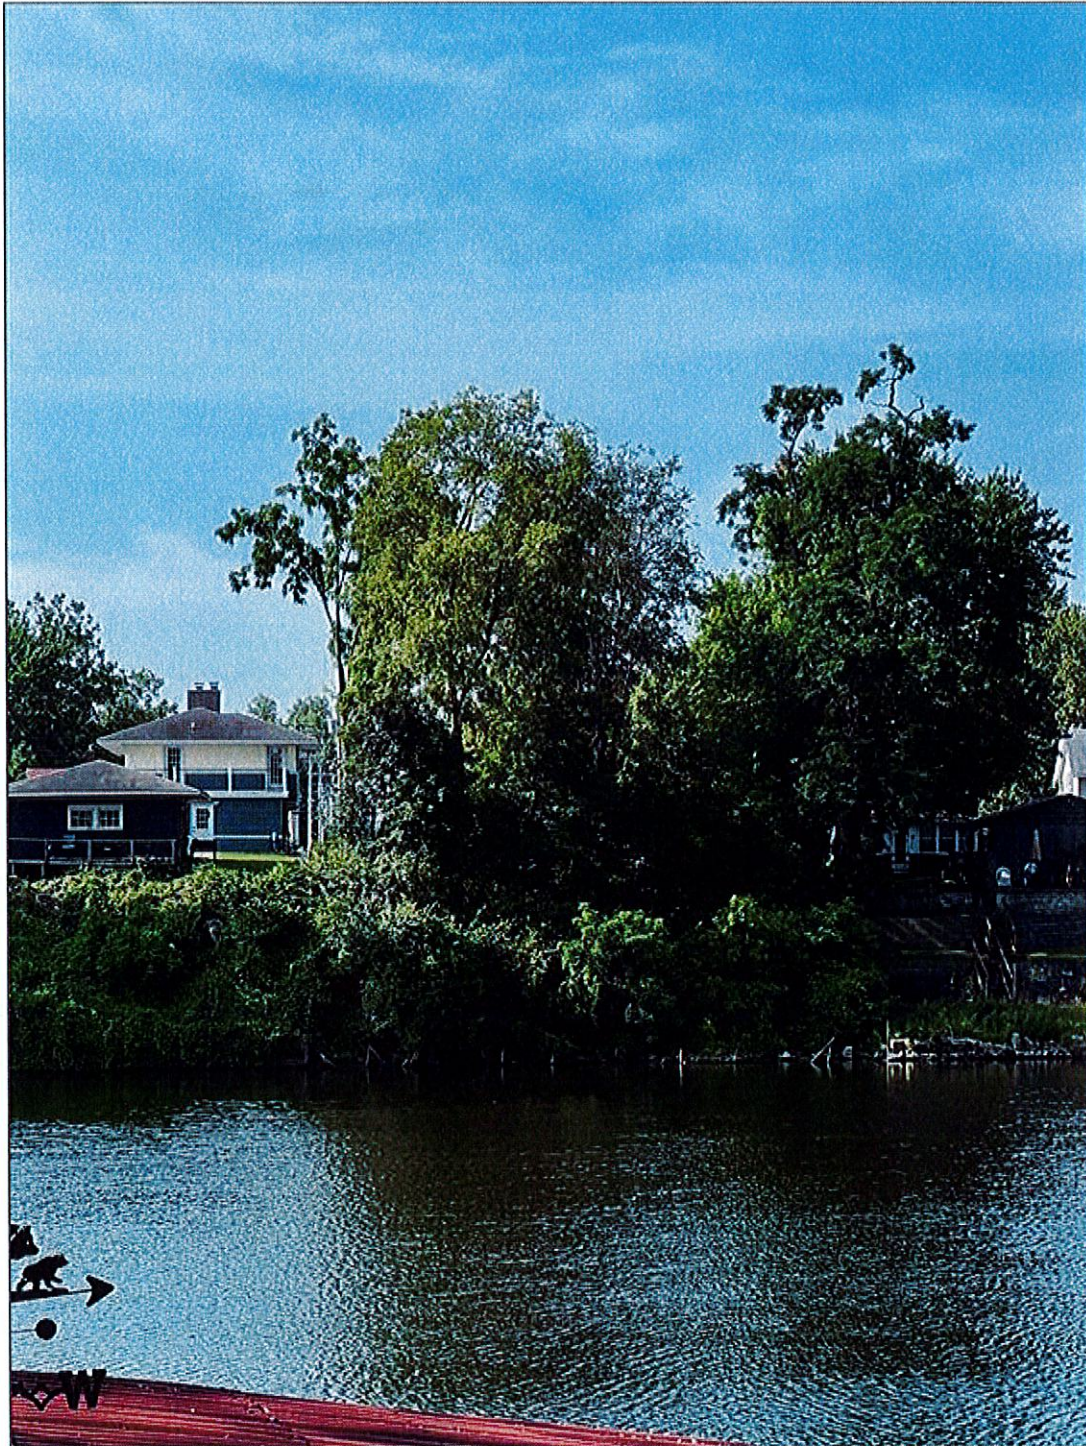CITY OF MISHAWAKA
THIRD STREET SEWER IMPROVEMENTS PHASE III
City Project No.: MWW-23-015




Photograph 2: Looking South From Northern Bank of the St. Joseph River Towards the Location of Proposed Storm Outfall

**CITY OF MISHAWAKA
THIRD STREET SEWER IMPROVEMENTS PHASE III
City Project No.: MWW-23-015**




Photograph 3: Existing Embankment Directly West of Proposed Outfall Location

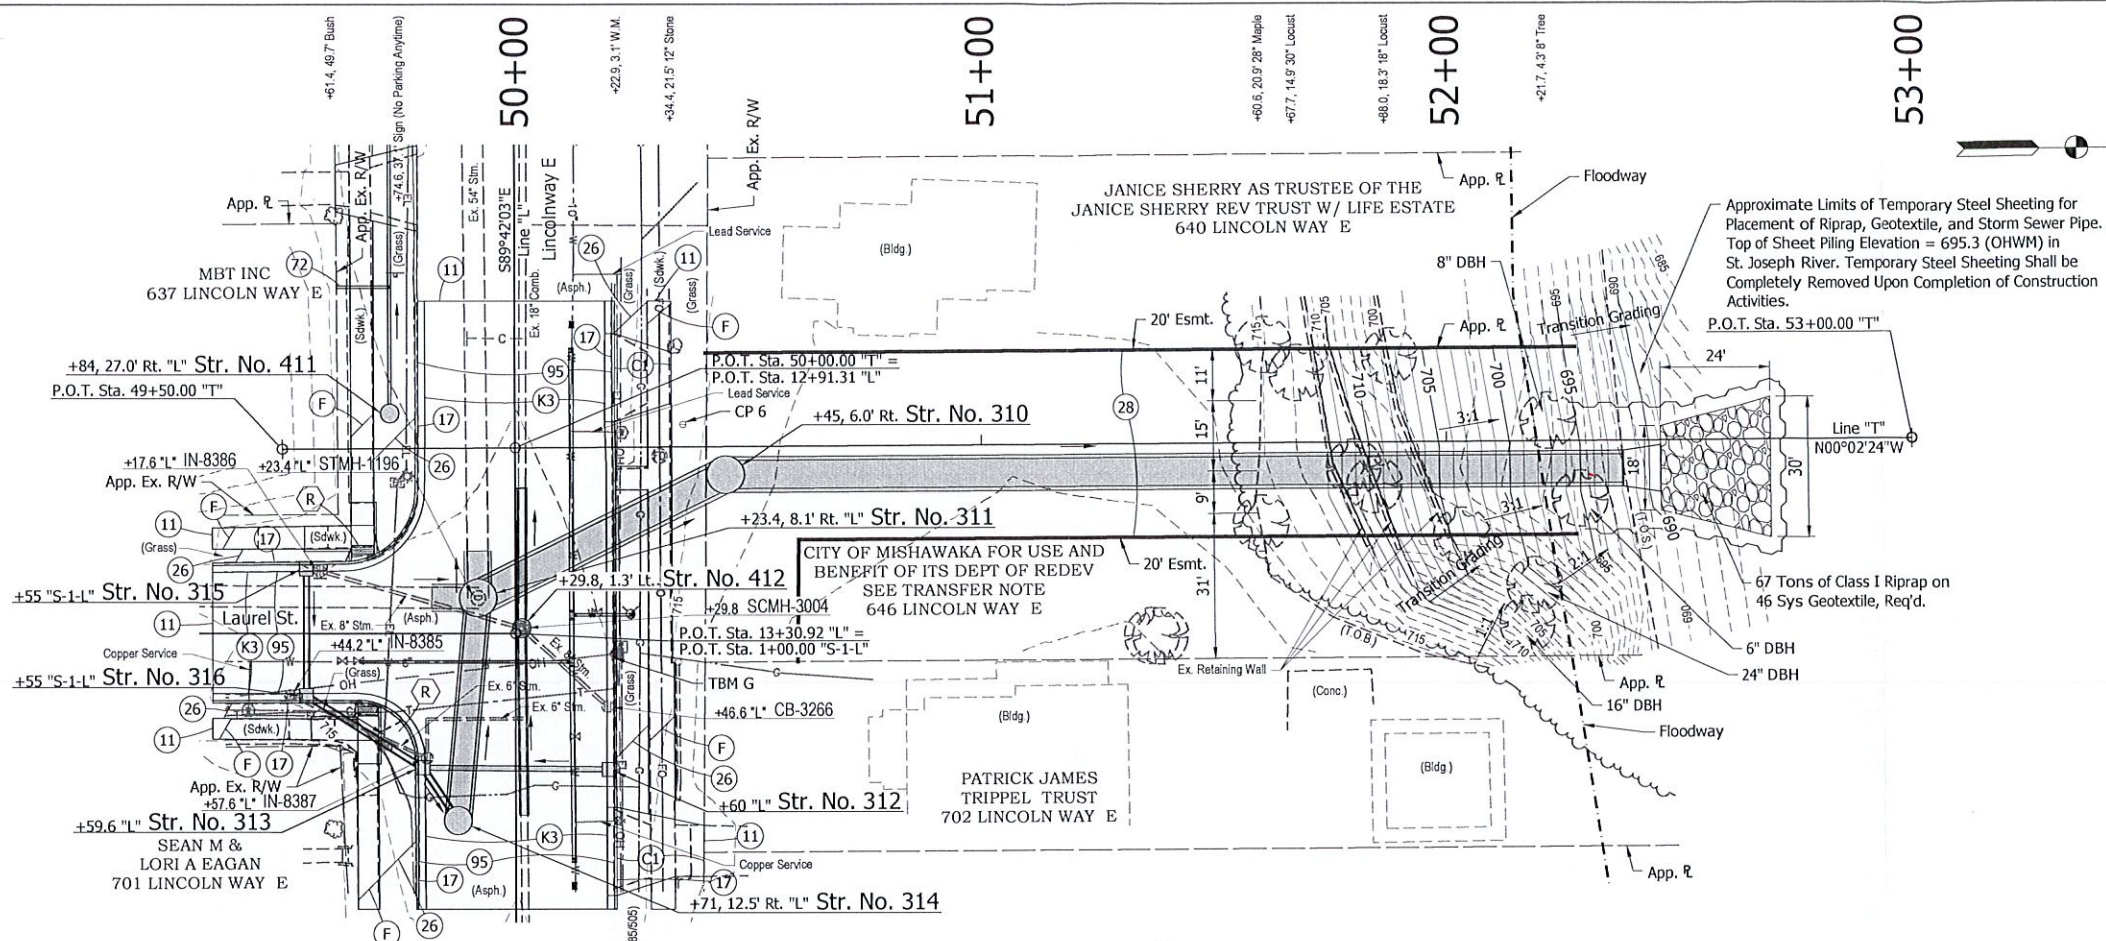GDH - 10/16/2024 1:48 PM - U:\2023\202336 MISH - Third Street Ph III Design\Cad\Eng Dwg\Third St. Ph. III Outfall Permit Application.dwg (P&P - OUTFALL - T)



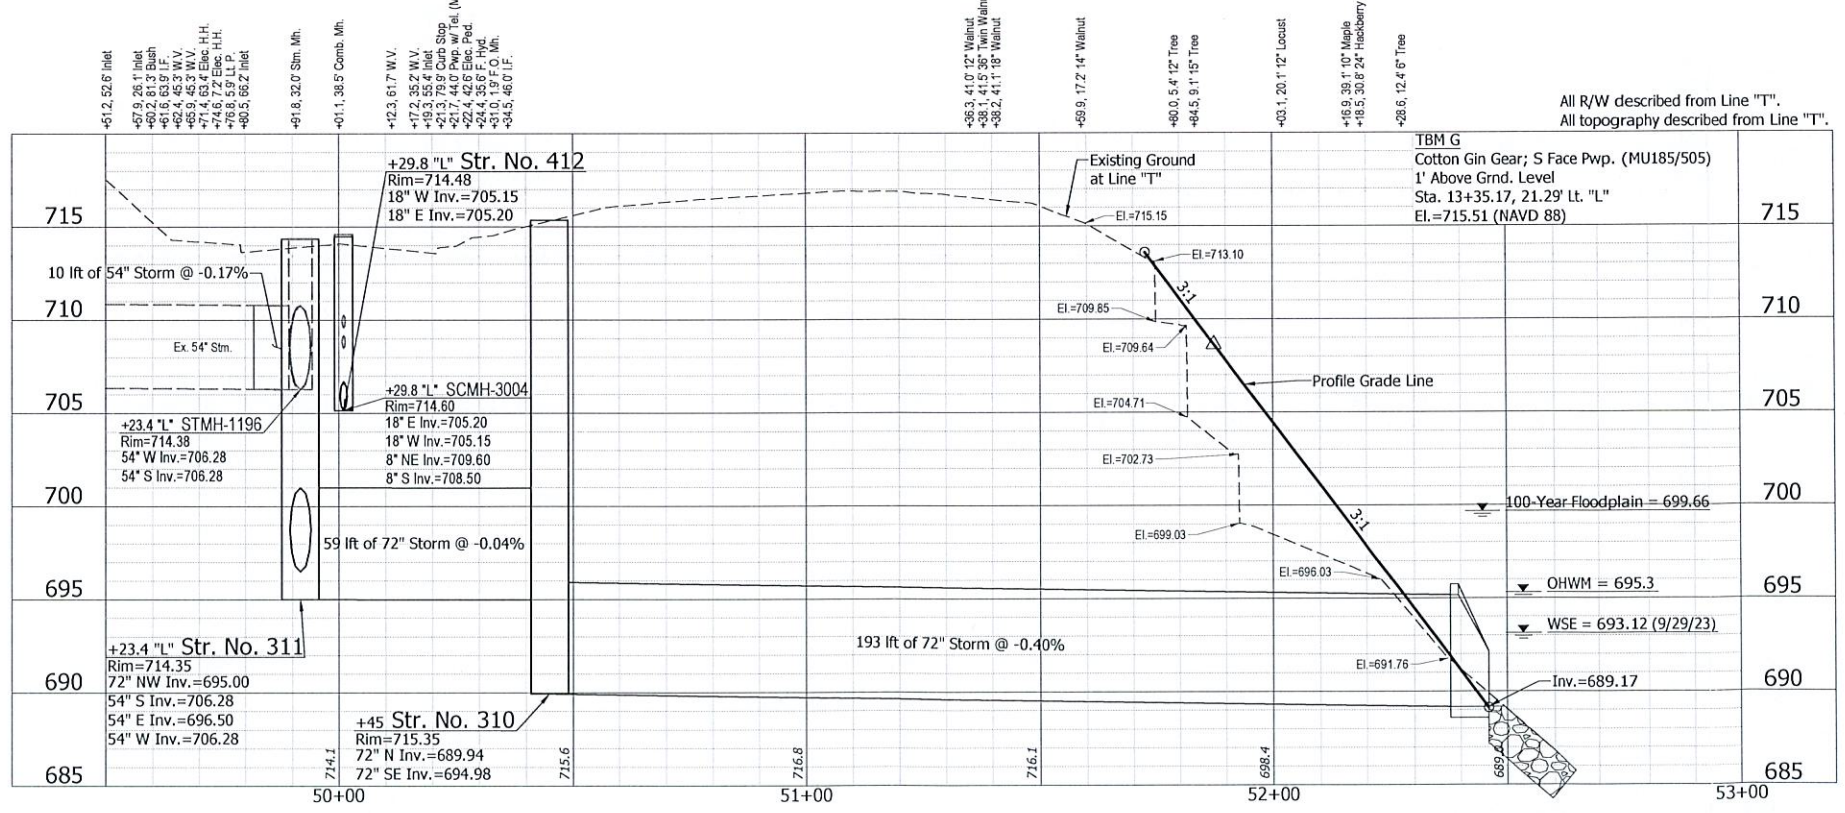+45, 6.0' Rt. Str. No. 310
 Storm Manhole, Type B w/ Casting Type R-1642
 193 lft of 72" Pipe @ 0.40% and
 1 - Concrete End Section Req'd.



NOTE:
 See Sheet 20 for retaining wall details.

- LEGEND:**
- (C1) Cement Concrete Pavement for Residential Drives, 6" w/ Fiber Reinforcement
 - (F) 4" Concrete Sidewalk
 - (K3) 165 #/sys HMA, Type "C", Surface on 275 #/sys HMA, Type "C", Intermediate on 660 #/sys HMA, Type "C", Base
 - (11) Saw Cut
 - (17) Combined Concrete Curb and Gutter
 - (26) Nursery Sodding
 - (28) Hydroseeding
 - (72) 6" Sanitary Lateral w/ Two-Way Cleanout (Exact Location to be Field Determined)
 - (95) Pavement Removal
 - (R) Concrete Curb Ramp



LFA
 LAWSON-FISHER ASSOCIATES P.C.
 525 W. WASHINGTON AVENUE
 SOUTH BEND, INDIANA 46601
 PH. (574) 234-3167

SIGNATURE _____ DATE _____

NOT FOR CONSTRUCTION

CITY OF MISHAWAKA, INDIANA
 THIRD STREET SEWER IMPROVEMENTS
 PHASE III
 PLAN AND PROFILE - LINE "T"
 STA. 49+50 TO STA. 53+00

REVISIONS	HORIZONTAL SCALE 1" = 20'	PROJECT NUMBER MWW-24-xxx
DRAWN: GDH	VERTICAL SCALE 1" = 5'	SHEETS 1 OF 2
CHECKED: DGD	SURVEY BOOK	DATE OCTOBER 2024

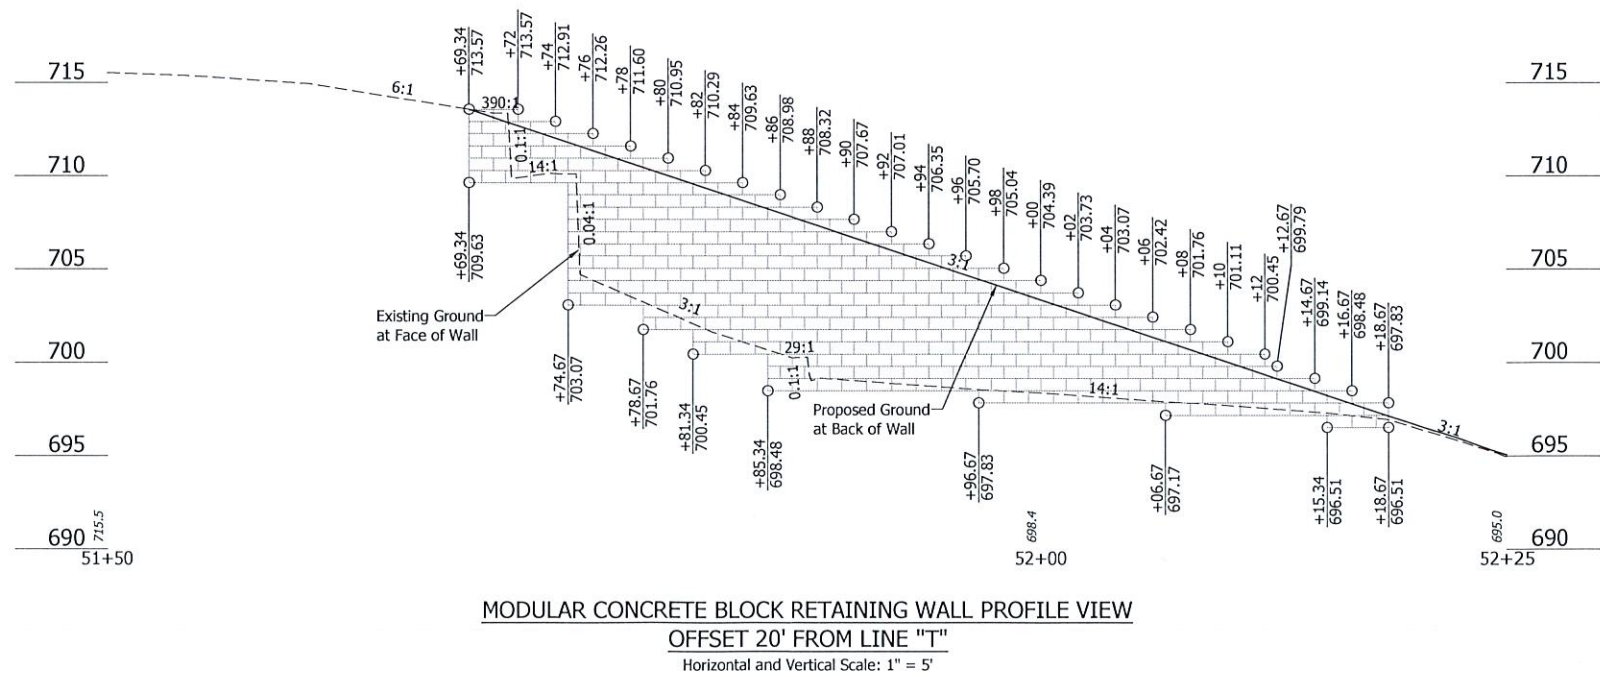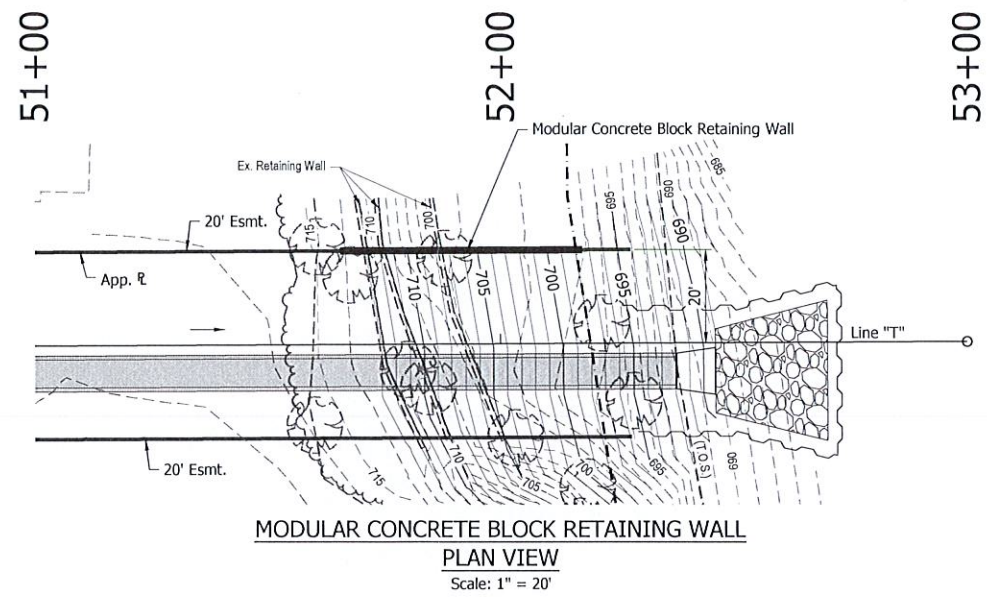

NOTE:
Modular concrete block retaining wall layout used 16" x 8" blocks.

GDH - 10/16/2024 1:48 PM - U:\2023\202336 MISH - Third Street Ph III Design\Cad\Eng Dwg\Concrete Block Wall Permit Application.dwg (CONST. DETAILS)

LFA
LAWSON-FISHER ASSOCIATES P.C.
525 W. WASHINGTON AVENUE
SOUTH BEND, INDIANA 46601
PH. (574) 234-3167

SIGNATURE	DATE

NOT FOR CONSTRUCTION

CITY OF MISHAWAKA, INDIANA
THIRD STREET SEWER IMPROVEMENTS
PHASE III
CONSTRUCTION DETAILS

REVISIONS	HORIZONTAL SCALE AS NOTED VERTICAL SCALE 1" = 5'	PROJECT NUMBER MWW-24-XXX
DRAWN: GDH	SURVEY BOOK	SHEETS
CHECKED: DGD	DATE OCTOBER 2024	2 OF 2